


BUILDING "D" TYP. FLOOR PLAN (4TH, 5TH, 6TH, 9TH AND 10TH FLOOR)

SCALE: 1/8"=1'-0"

6" FLOOR DOWN (F.D.) TYPE "C"
CAST IRON BODY WITH CAST IRON
TOP HEAVY DUTY PARKING GARTE
SERIES BY AISC
SEE DETAIL ON DWG. No. A-22

3" FLOOR DOWN (F.D.) TYPE "C"
CAST IRON BODY WITH CAST IRON
TOP HEAVY DUTY PARKING GARTE
SERIES BY AISC
SEE DETAIL ON DWG. No. A-22

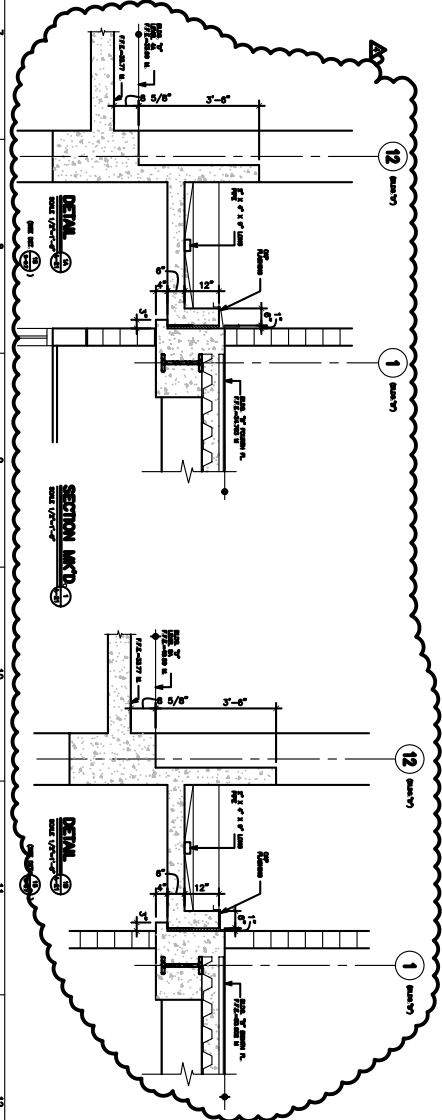

FERNANDO IRIZARRY ARCHITECTS, P.S.C.
(787) 754-4296 765-7027 P.O. BOX 16100
SAN JUAN, PUERTO RICO 00916
OFFICE AT: 650 PONCE DE LEON AVE.
HATO REY, PUERTO RICO 00917
Email: info@fiaz.com

THIS DRAWING OR COPY IS PROPERTY OF
THE OFFICE OF FERNANDO IRIZARRY
ARCHITECTS AND SHALL BE USED AS
INSTRUMENT OF WORK BY PERSONS DULY
AUTHORIZED BY FERNANDO IRIZARRY
ARCHITECTS. NO PART OF THESE DRAWINGS
SHALL BE REPRODUCED IN ANY FORM.

BUILDING "D" TYP. FLOOR PLAN (4TH, 5TH, 6TH, 9TH AND 10TH FLOOR)
A-21

METRO MEDICAL CENTER,
BAYAMON, PUERTO RICO

ROBERTO L. REXACH CINTRON
site engineer
JORGE L. ROBERT
structural engineer
MIGUEL CORTES
electrical engineer
PEDRO MEDINA
mechanical engineer

Project: METRO MEDICAL CENTER, BAYAMON, PUERTO RICO
Drawn by: JORGE L. ROBERT
Checked by: JORGE L. ROBERT
Date: 02-02-04
Drawn by: JORGE L. ROBERT
Checked by: JORGE L. ROBERT
Date: 02-02-04
Drawn by: JORGE L. ROBERT
Checked by: JORGE L. ROBERT
Date: 02-02-04