



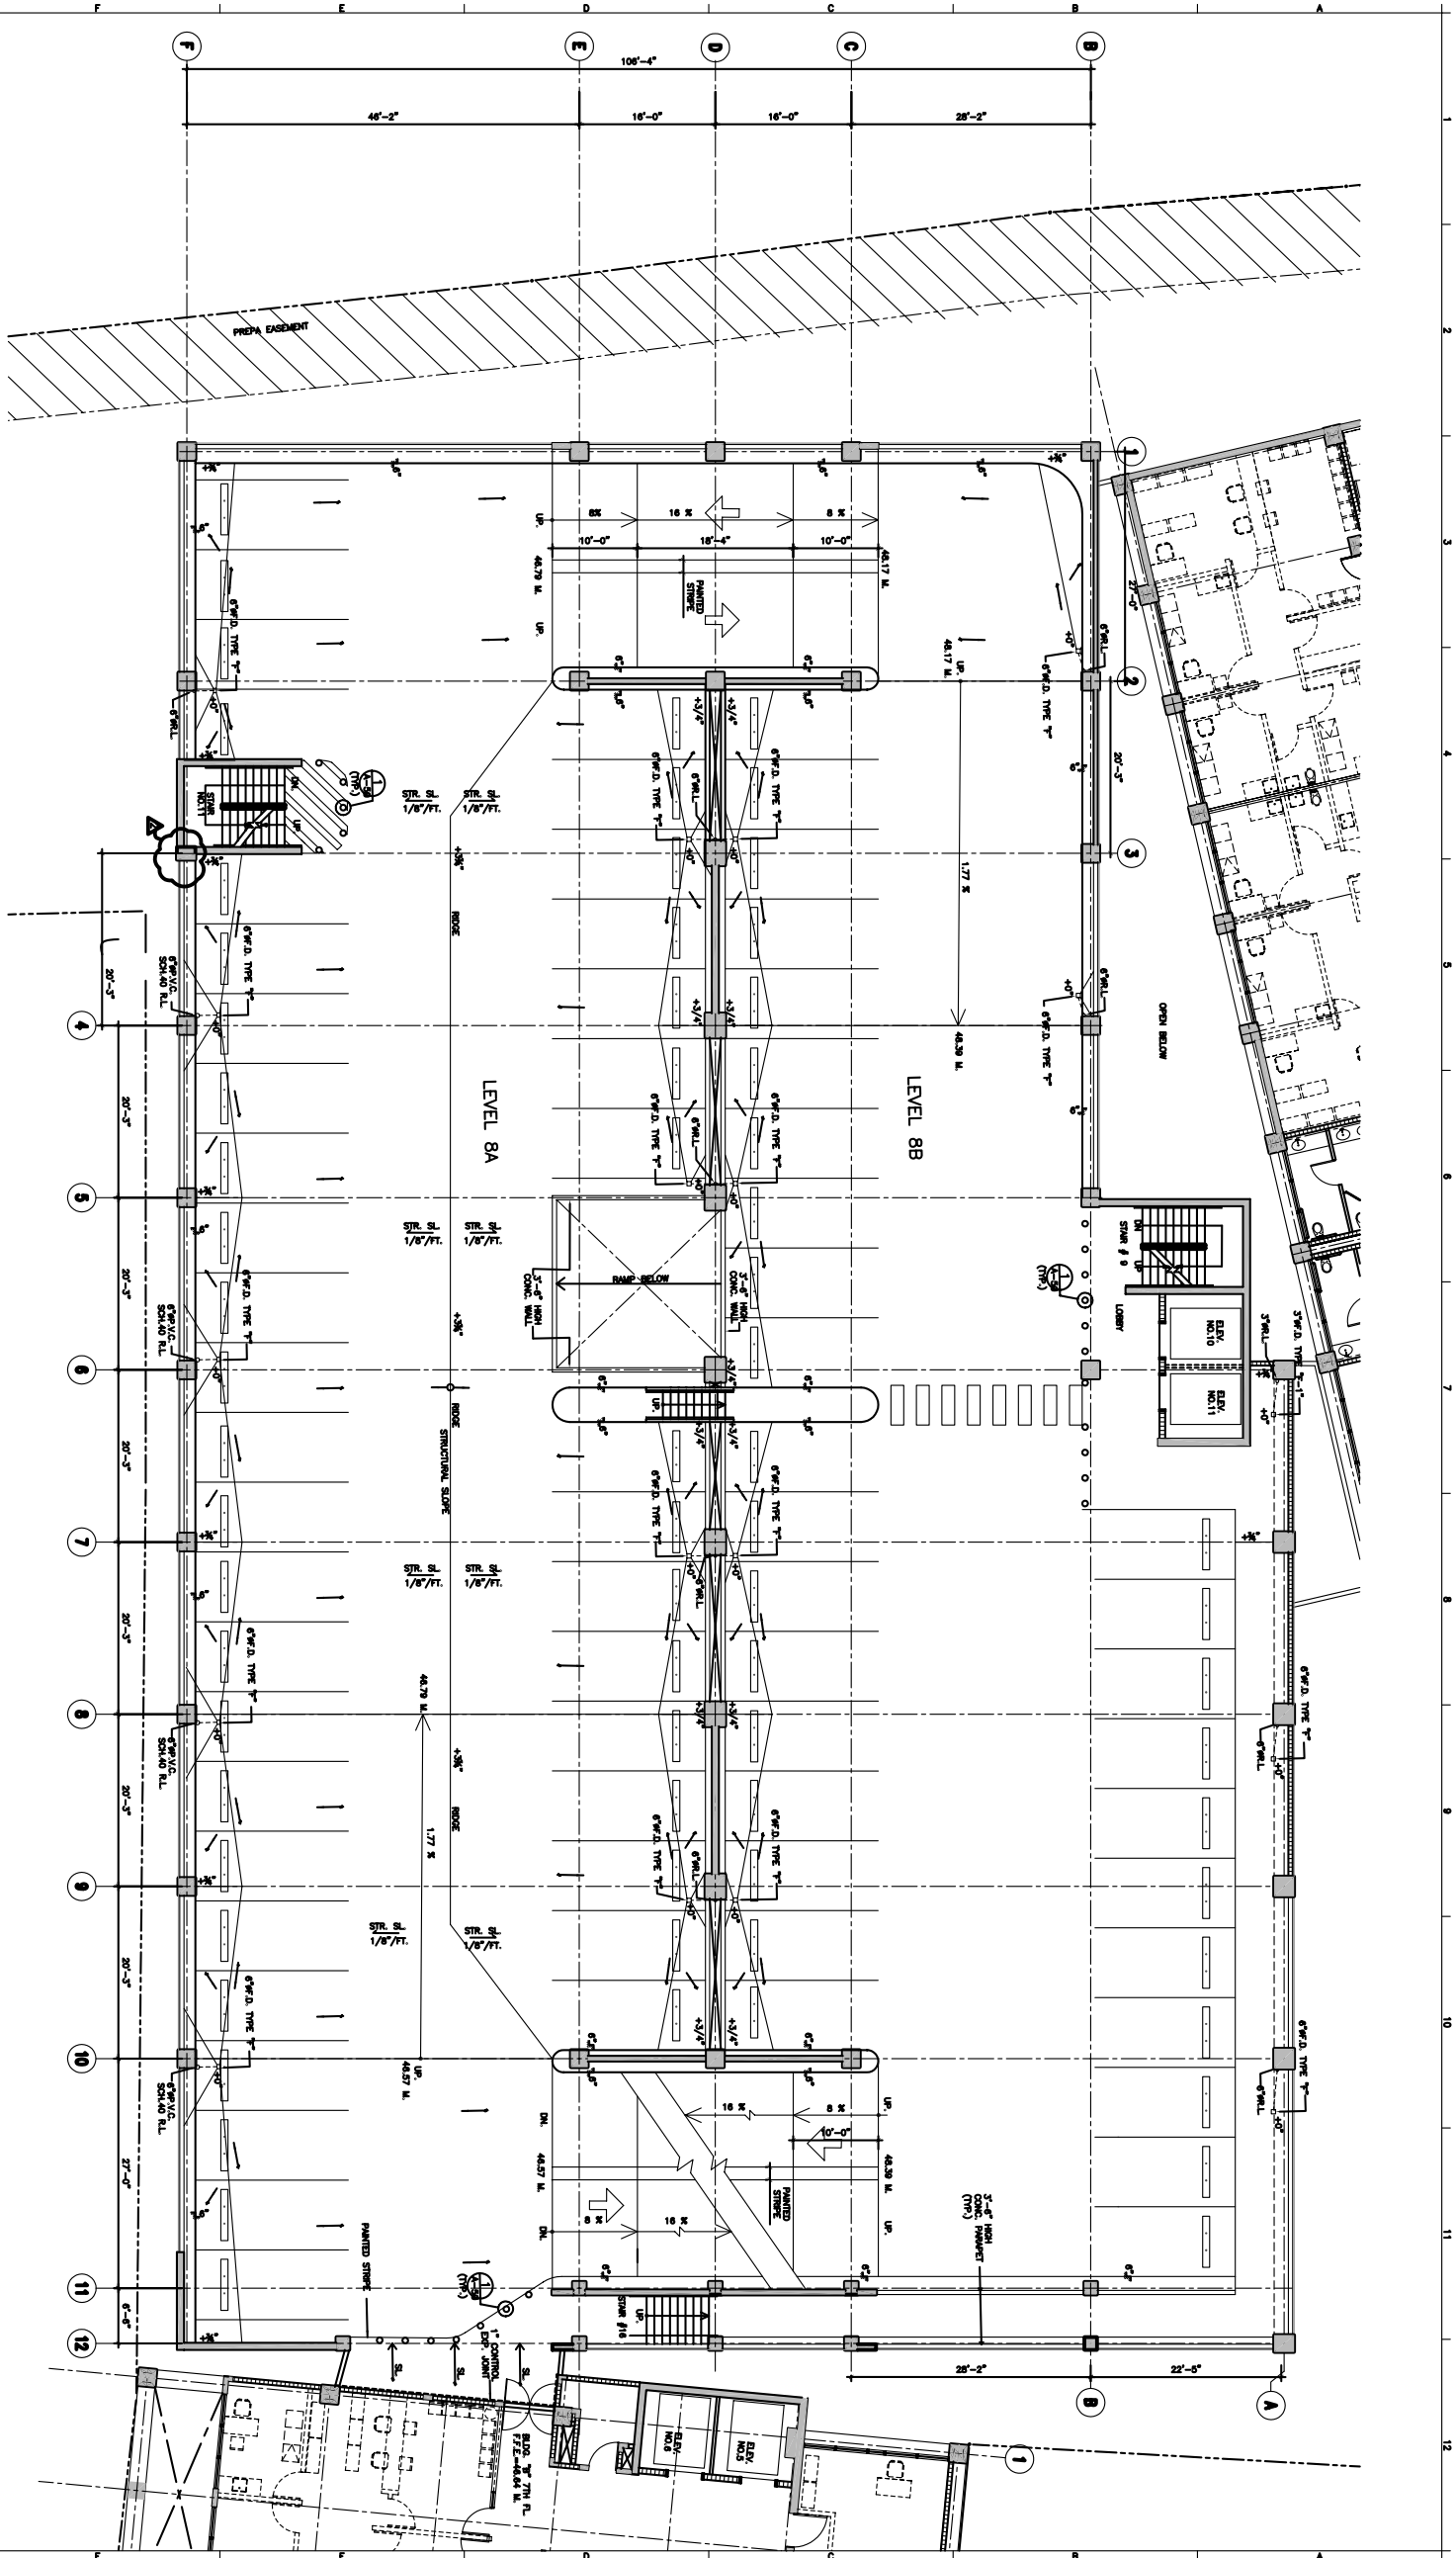

BUILDING "D" 8TH FLOOR PLAN
SCALE: 1/8"=1'-0"

6" FLOOR DRUM (F.D.) TYPE "C"
CAST IRON BODY WITH CAST IRON
TOP HEAVY DUTY PAVING GRATE
SERIES BY JCSM
SEE DETAIL ON DWG. No. A-22

3" FLOOR DRUM (F.D.) TYPE "C"
CAST IRON BODY WITH CAST IRON
TOP HEAVY DUTY PAVING GRATE
SERIES BY JCSM
SEE DETAIL ON DWG. No. A-22

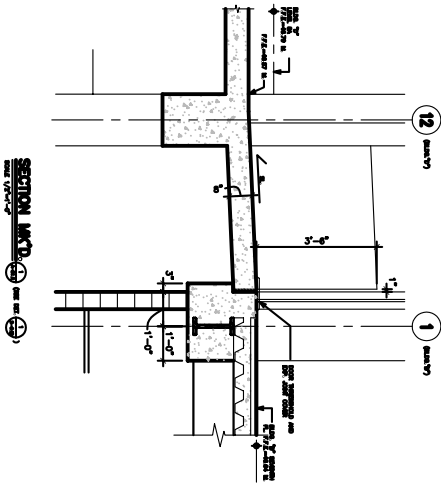


FERNANDO IRIZARRY
ARCHITECTS, P.S.C.
(787) 764-4296 / 765-7027 P.O. BOX 16100
SAN JUAN, PUERTO RICO 00916
OFFICE AT: 650 PONCE DE LEON AVE.
HATO REY, PUERTO RICO 00917
Email: info@fiaz.com

THIS DRAWING OR COPY IS PROPERTY OF
THE OFFICE OF FERNANDO IRIZARRY
ARCHITECTS AND SHALL BE USED AS
INSTRUMENT OF WORK BY PERSONS DULY
AUTHORIZED BY FERNANDO IRIZARRY
ARCHITECTS. NO PART OF THESE DRAWINGS
SHALL BE REPRODUCED IN ANY FORM.

METRO MEDICAL CENTER,
BAYAMON, PUERTO RICO

Project	0218
Drawn by	0218
Checked by	0218
Date	02-02-04
No. Revision	Date
1	04/04/04

 ROBERTO L. REXACH CINTRON
site engineer
JORGE L. ROBERT
structural engineer
MIGUEL CORTES
electrical engineer
PEDRO MEDINA
mechanical engineer



BUILDING "D"
8TH FLOOR PLAN
DWG. NO.
A-21.2