
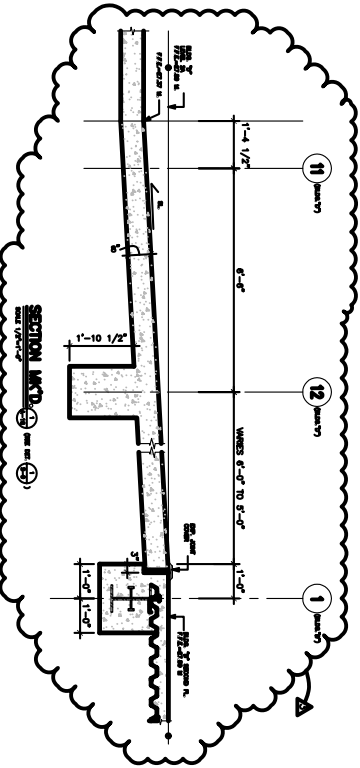


BUILDING "D" SECOND FLOOR PLAN

SCALE: 1/8"=1'-0"
0'9" FLOOR DIMS (F.S.) SEE L.C.
DO NOT SCALE FROM THIS DRAWING
ALL DIMENSIONS ARE IN FEET AND INCHES
UNLESS OTHERWISE NOTED
SEE GENERAL NOTES ON SHEET NO.

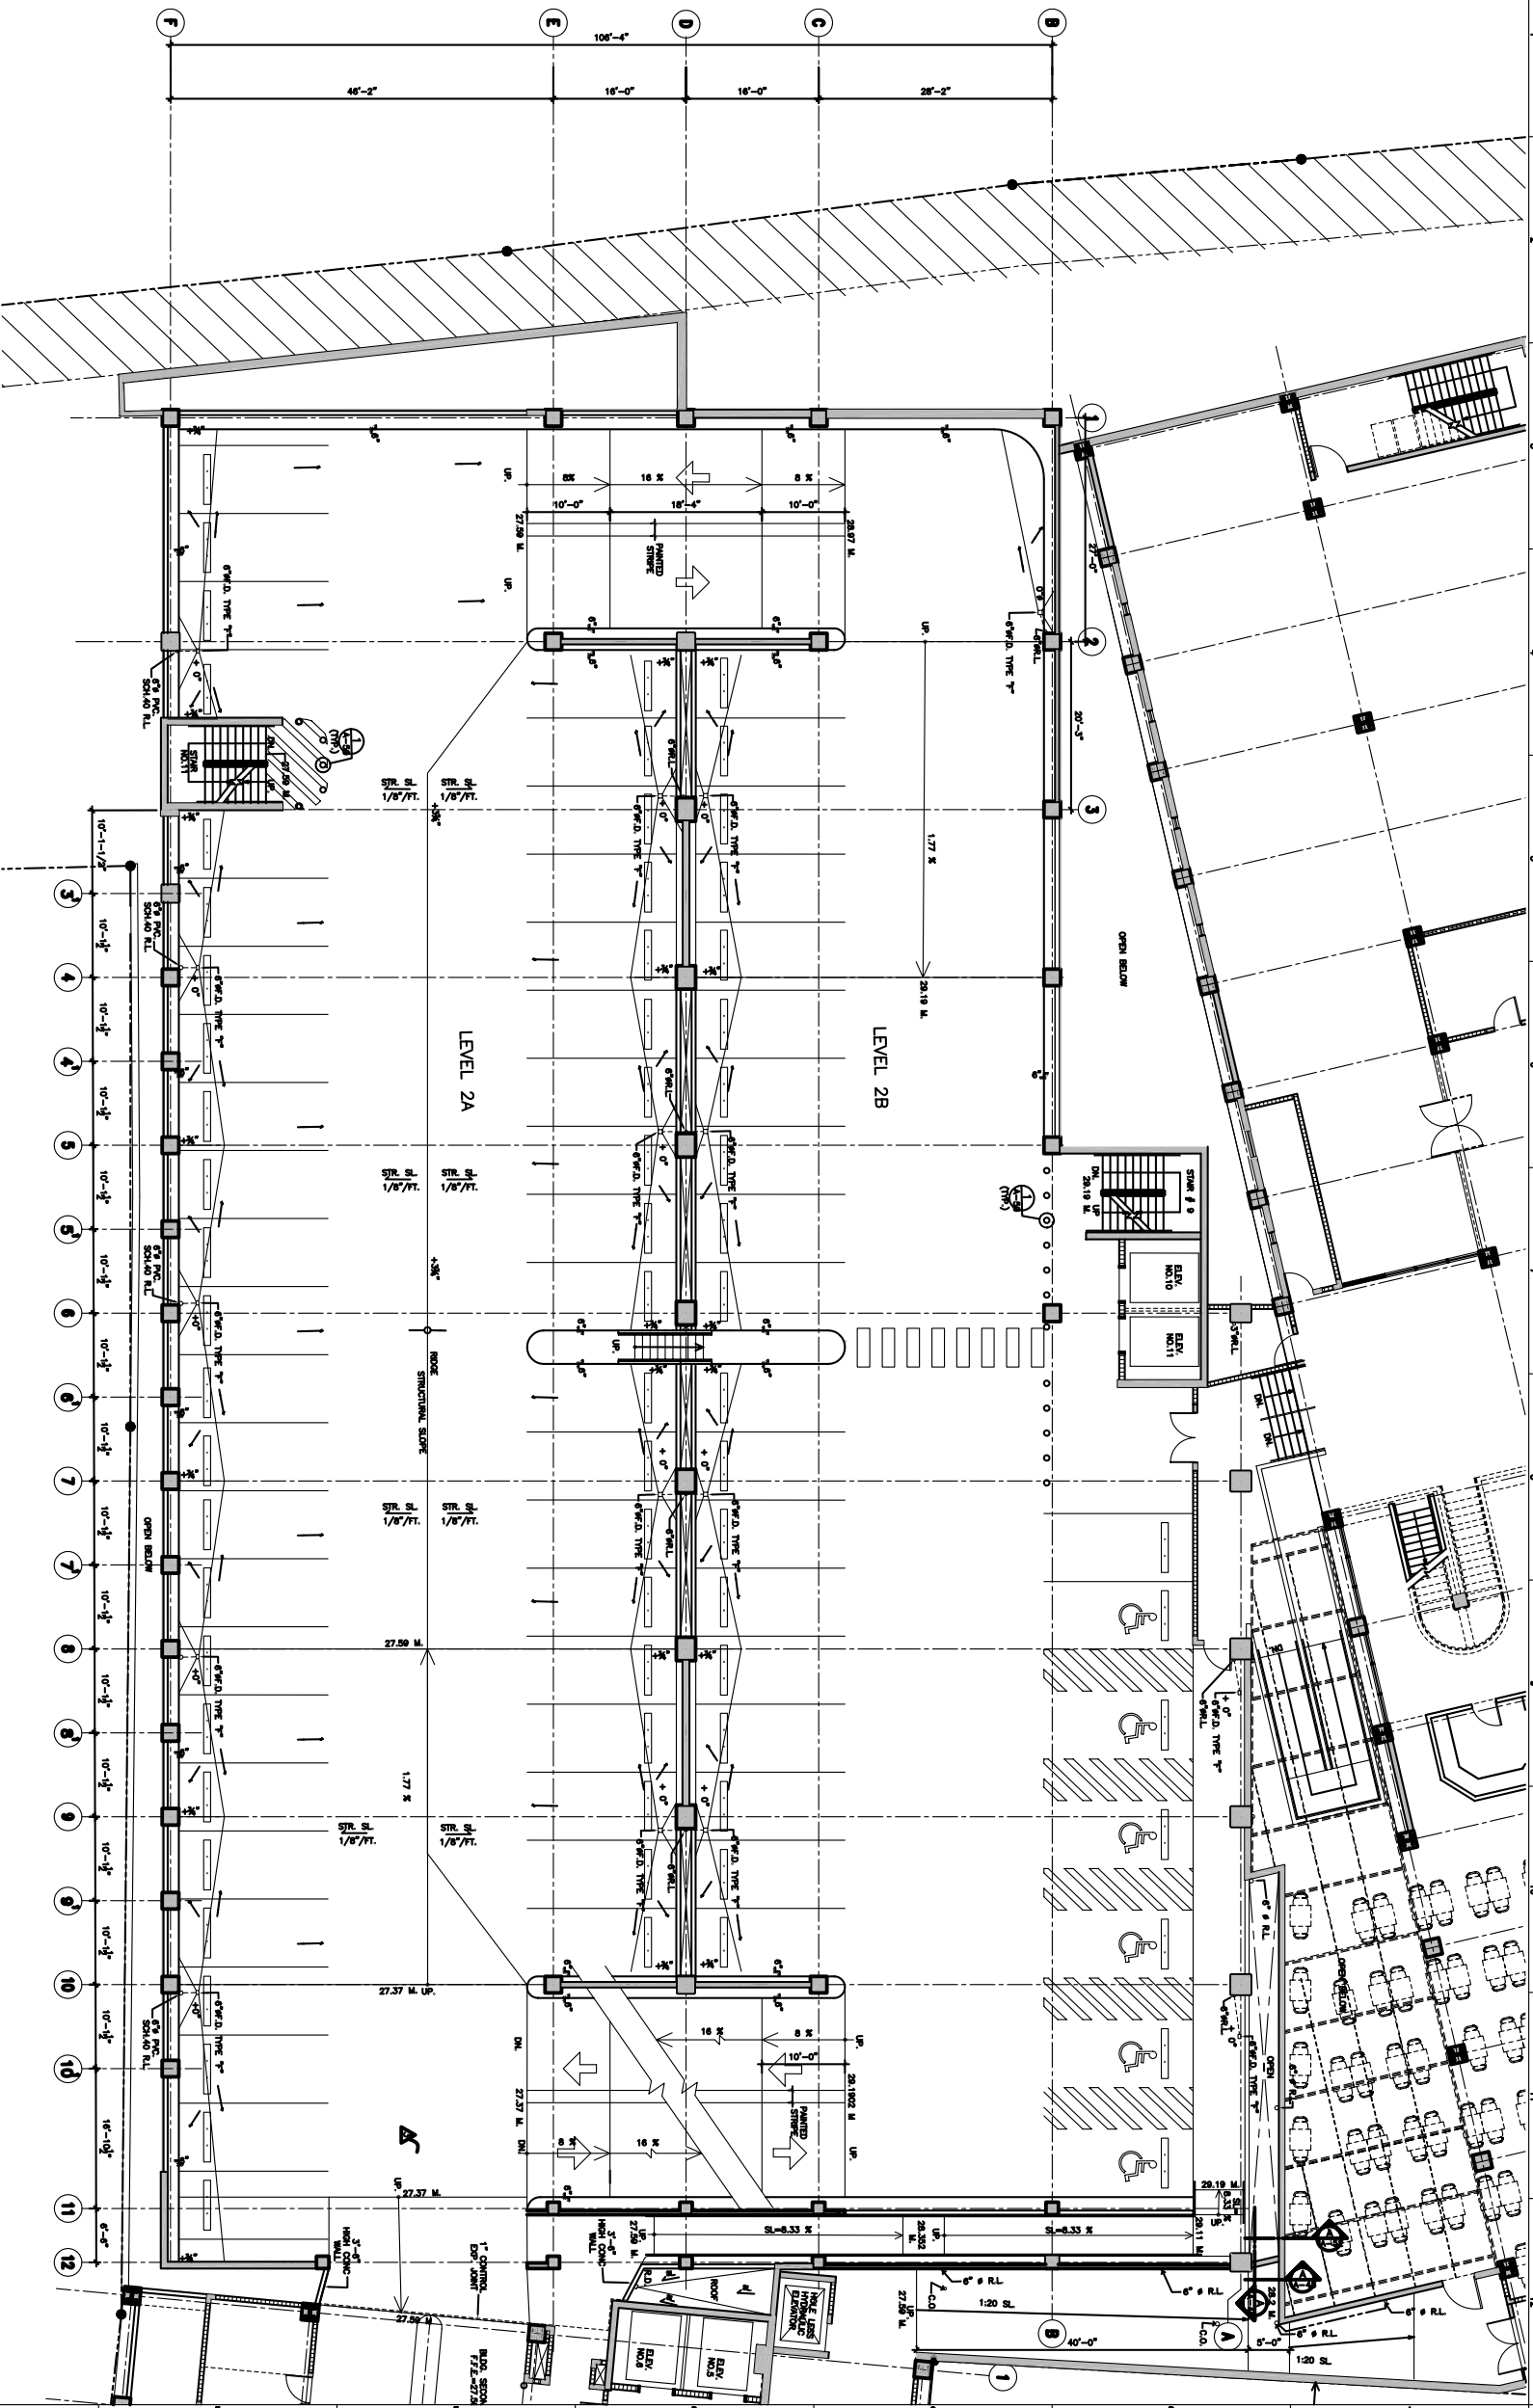

FERNANDO IRIZARRY
ARCHITECTS, P.S.C.
(787) 764-4296 765-7027 P.O. BOX 16100
SAN JUAN, PUERTO RICO 00916
OFFICE AT: 166 PONCE DE LEON AVE.
HATO REY, PUERTO RICO 00917
Email: info@irizarry.com

THIS DRAWING OR COPY IS PROPERTY OF
THE OFFICE OF FERNANDO IRIZARRY
ARCHITECTS AND SHALL BE USED AS
INSTRUMENT OF WORK BY PERSONS DULY
AUTHORIZED BY FERNANDO IRIZARRY
ARCHITECTS. NO PART OF THESE DRAWINGS
SHALL BE REPRODUCED IN ANY FORM.

METRO MEDICAL CENTER,
BAYAMON, PUERTO RICO

Project: METRO MEDICAL CENTER,
BAYAMON, PUERTO RICO
Date: 07-06-04
Checked by: [Signature]
Drawn by: [Signature]
Year: 2002
Sheet: 1 of 1

ROBERTO L. REXACH CINTRON
site engineer
JORGE L. ROBERT
structural engineer
MIGUEL CORTES
electrical engineer
PEDRO MEDINA
mechanical engineer



BUILDING "D"
SECOND FLOOR
PLAN

SHEET NO.
A-19