


BUILDING "D" 7TH. FLOOR PLAN
SCALE: 1/8"=1'-0"

6TH FLOOR DRAWN (F.D.) TYPE "C"
CAST IRON ROOF WITH CAST IRON
TOP HEAVY DUTY PAVING GRATE
BY AISCAL, SIMILAR TO 20010 SERIES
SEE DETAIL ON DWG. No. A-22

3TH FLOOR DRAWN (F.D.) TYPE "C"
CAST IRON ROOF WITH CAST IRON
TOP HEAVY DUTY PAVING GRATE
BY AISCAL, SIMILAR TO 20010 SERIES
SEE DETAIL ON DWG. No. A-22

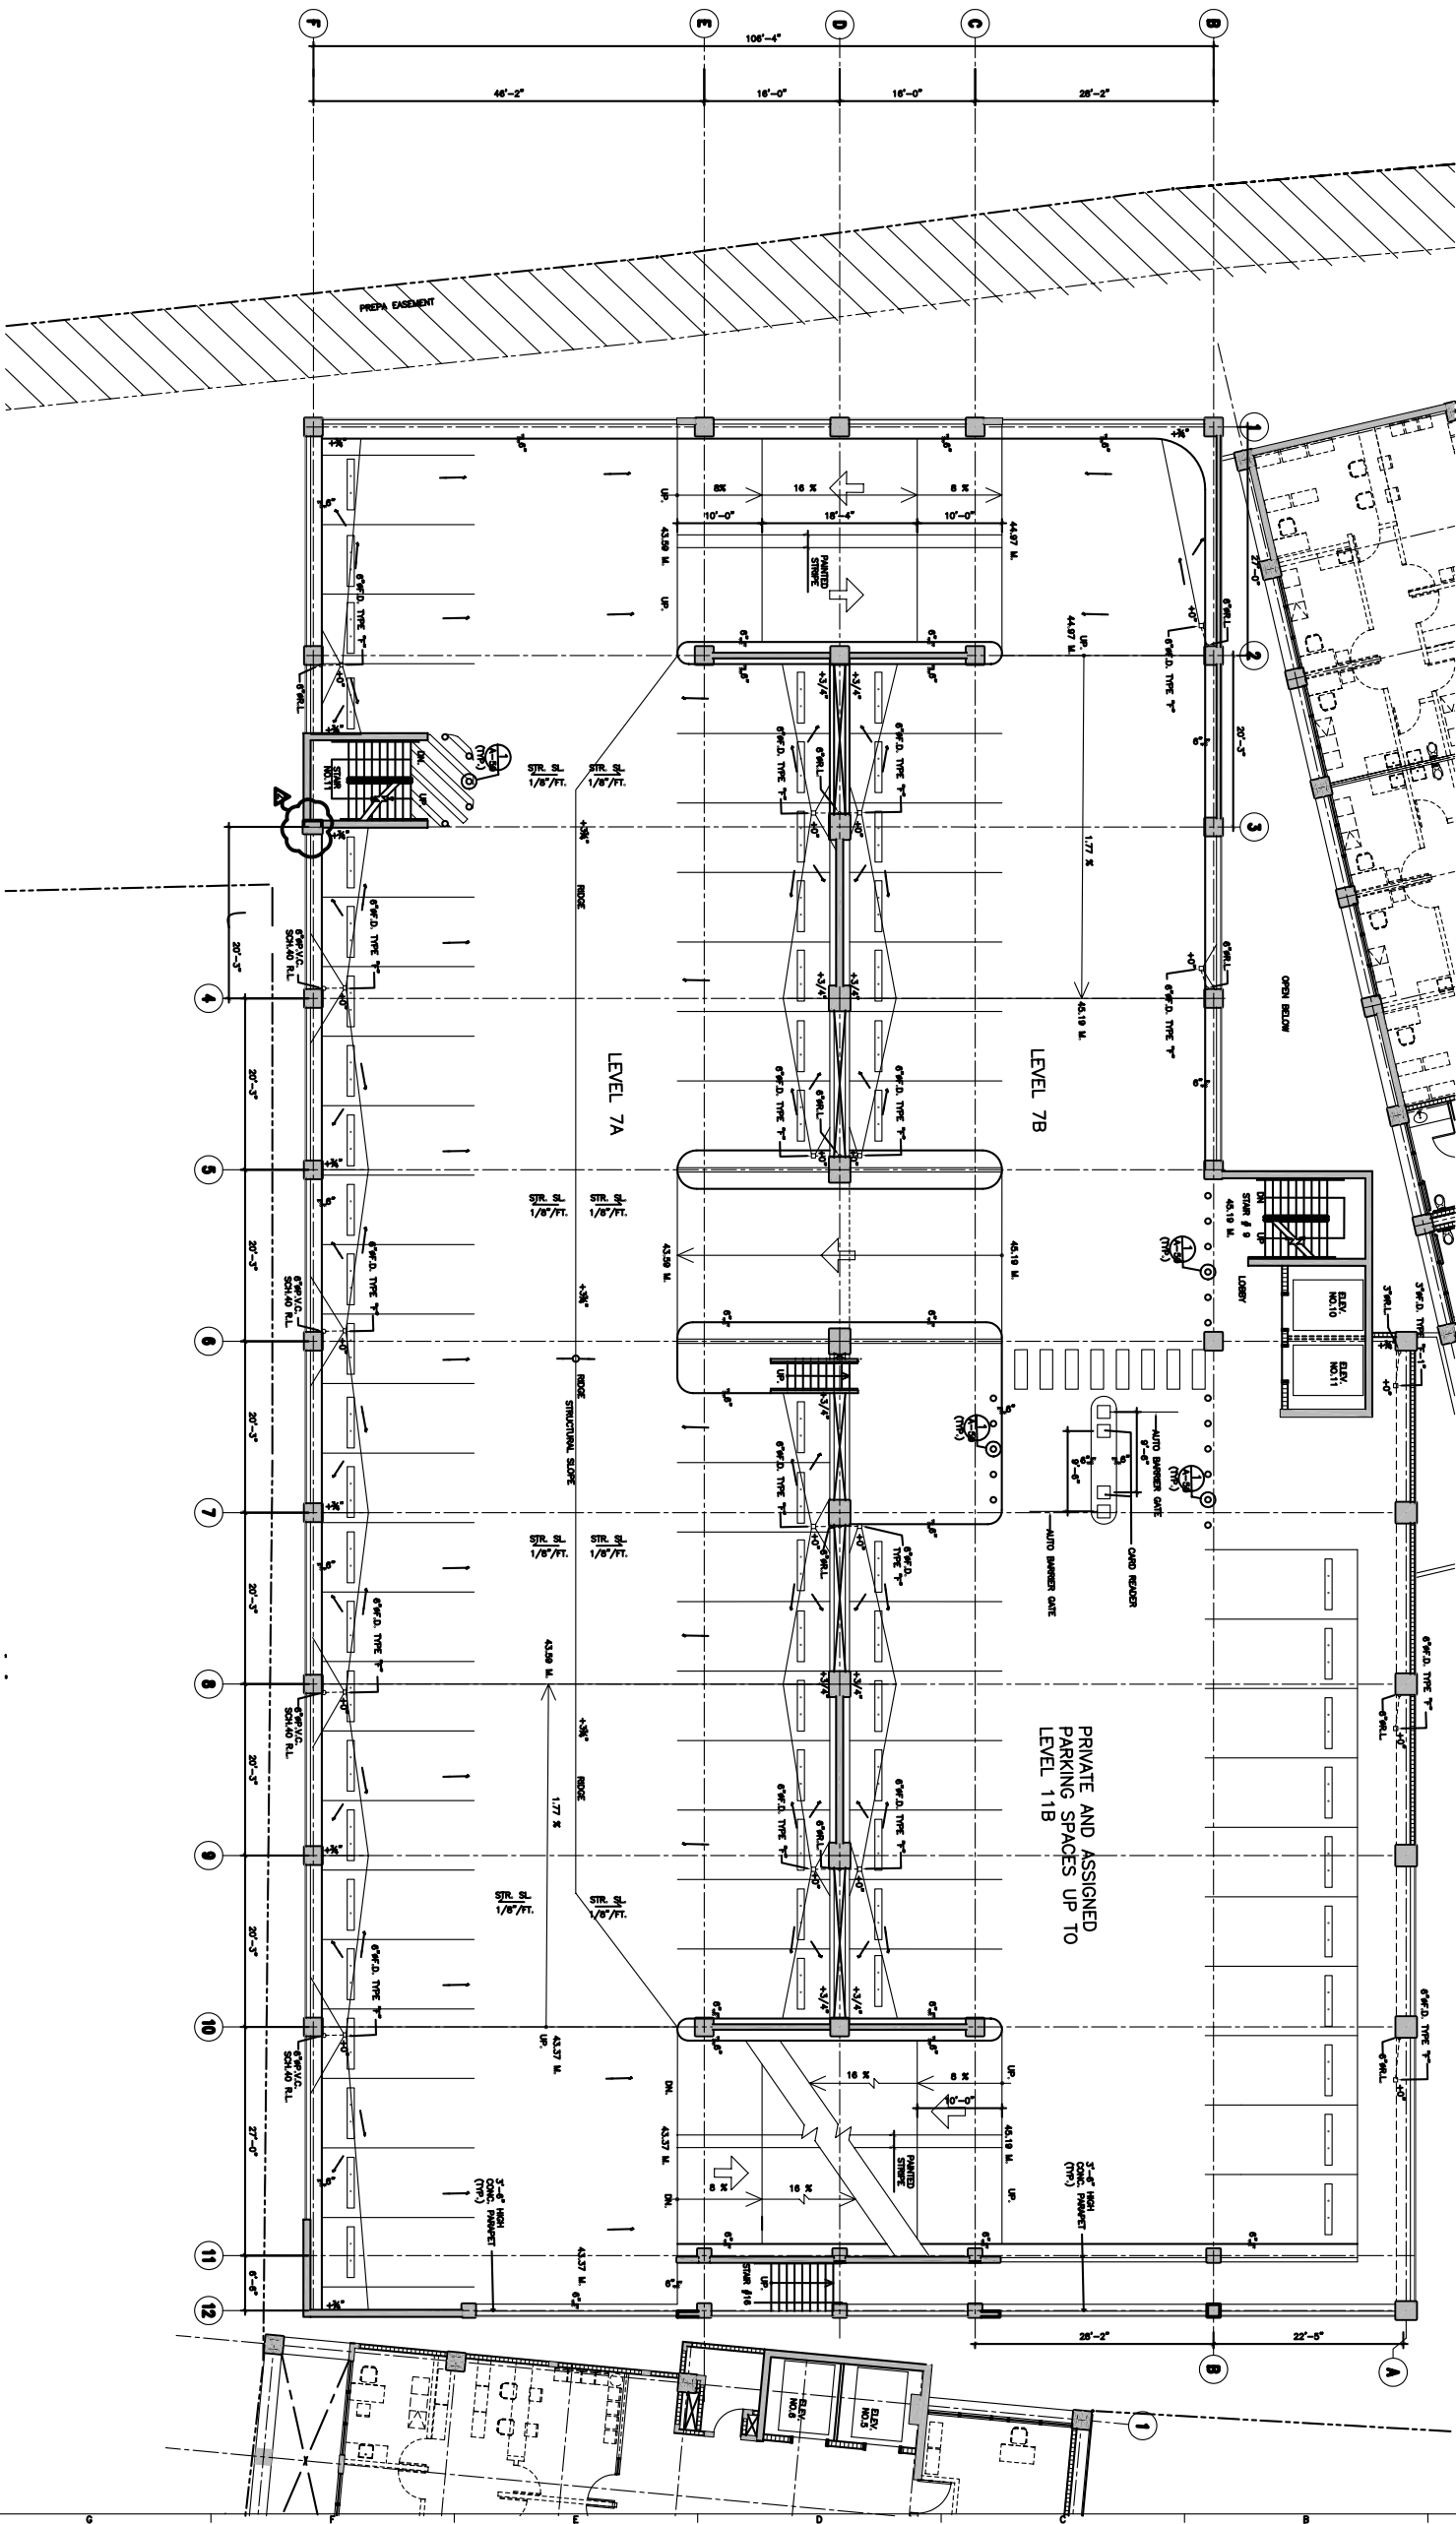

FERNANDO IRIZARRY ARCHITECTS, P.S.C.
(787) 764-4296 / 765-7027 P.O. BOX 16100
SAN JUAN, PUERTO RICO 00916
OFFICE AT: 656 PONCE DE LEON AVE.
HATO REY, PUERTO RICO 00917
Email: info@fiaz.com


THIS DRAWING OR COPY IS PROPERTY OF THE OFFICE OF FERNANDO IRIZARRY ARCHITECTS AND SHALL BE USED AS INSTRUMENT OF WORK BY PERSONS DULY AUTHORIZED BY FERNANDO IRIZARRY ARCHITECTS. NO PART OF THESE DRAWINGS SHALL BE REPRODUCED IN ANY FORM.

METRO MEDICAL CENTER,
BAYAMON, PUERTO RICO

Project: METRO MEDICAL CENTER, BAYAMON, PUERTO RICO
Drawing: 0218-AF04
Scale: 1/8"=1'-0"

Drawn by: [Signature]
Checked by: [Signature]
Date: 02-02-04

 ROBERTO L. REXACH CINTRON
site engineer
JORGE L. ROBERT
structural engineer
MIGUEL CORTES
electrical engineer
PEDRO MEDINA
mechanical engineer



SHEET TITLE
BUILDING "D" 7TH. FLOOR PLAN
DWG. NO. A-21.1